


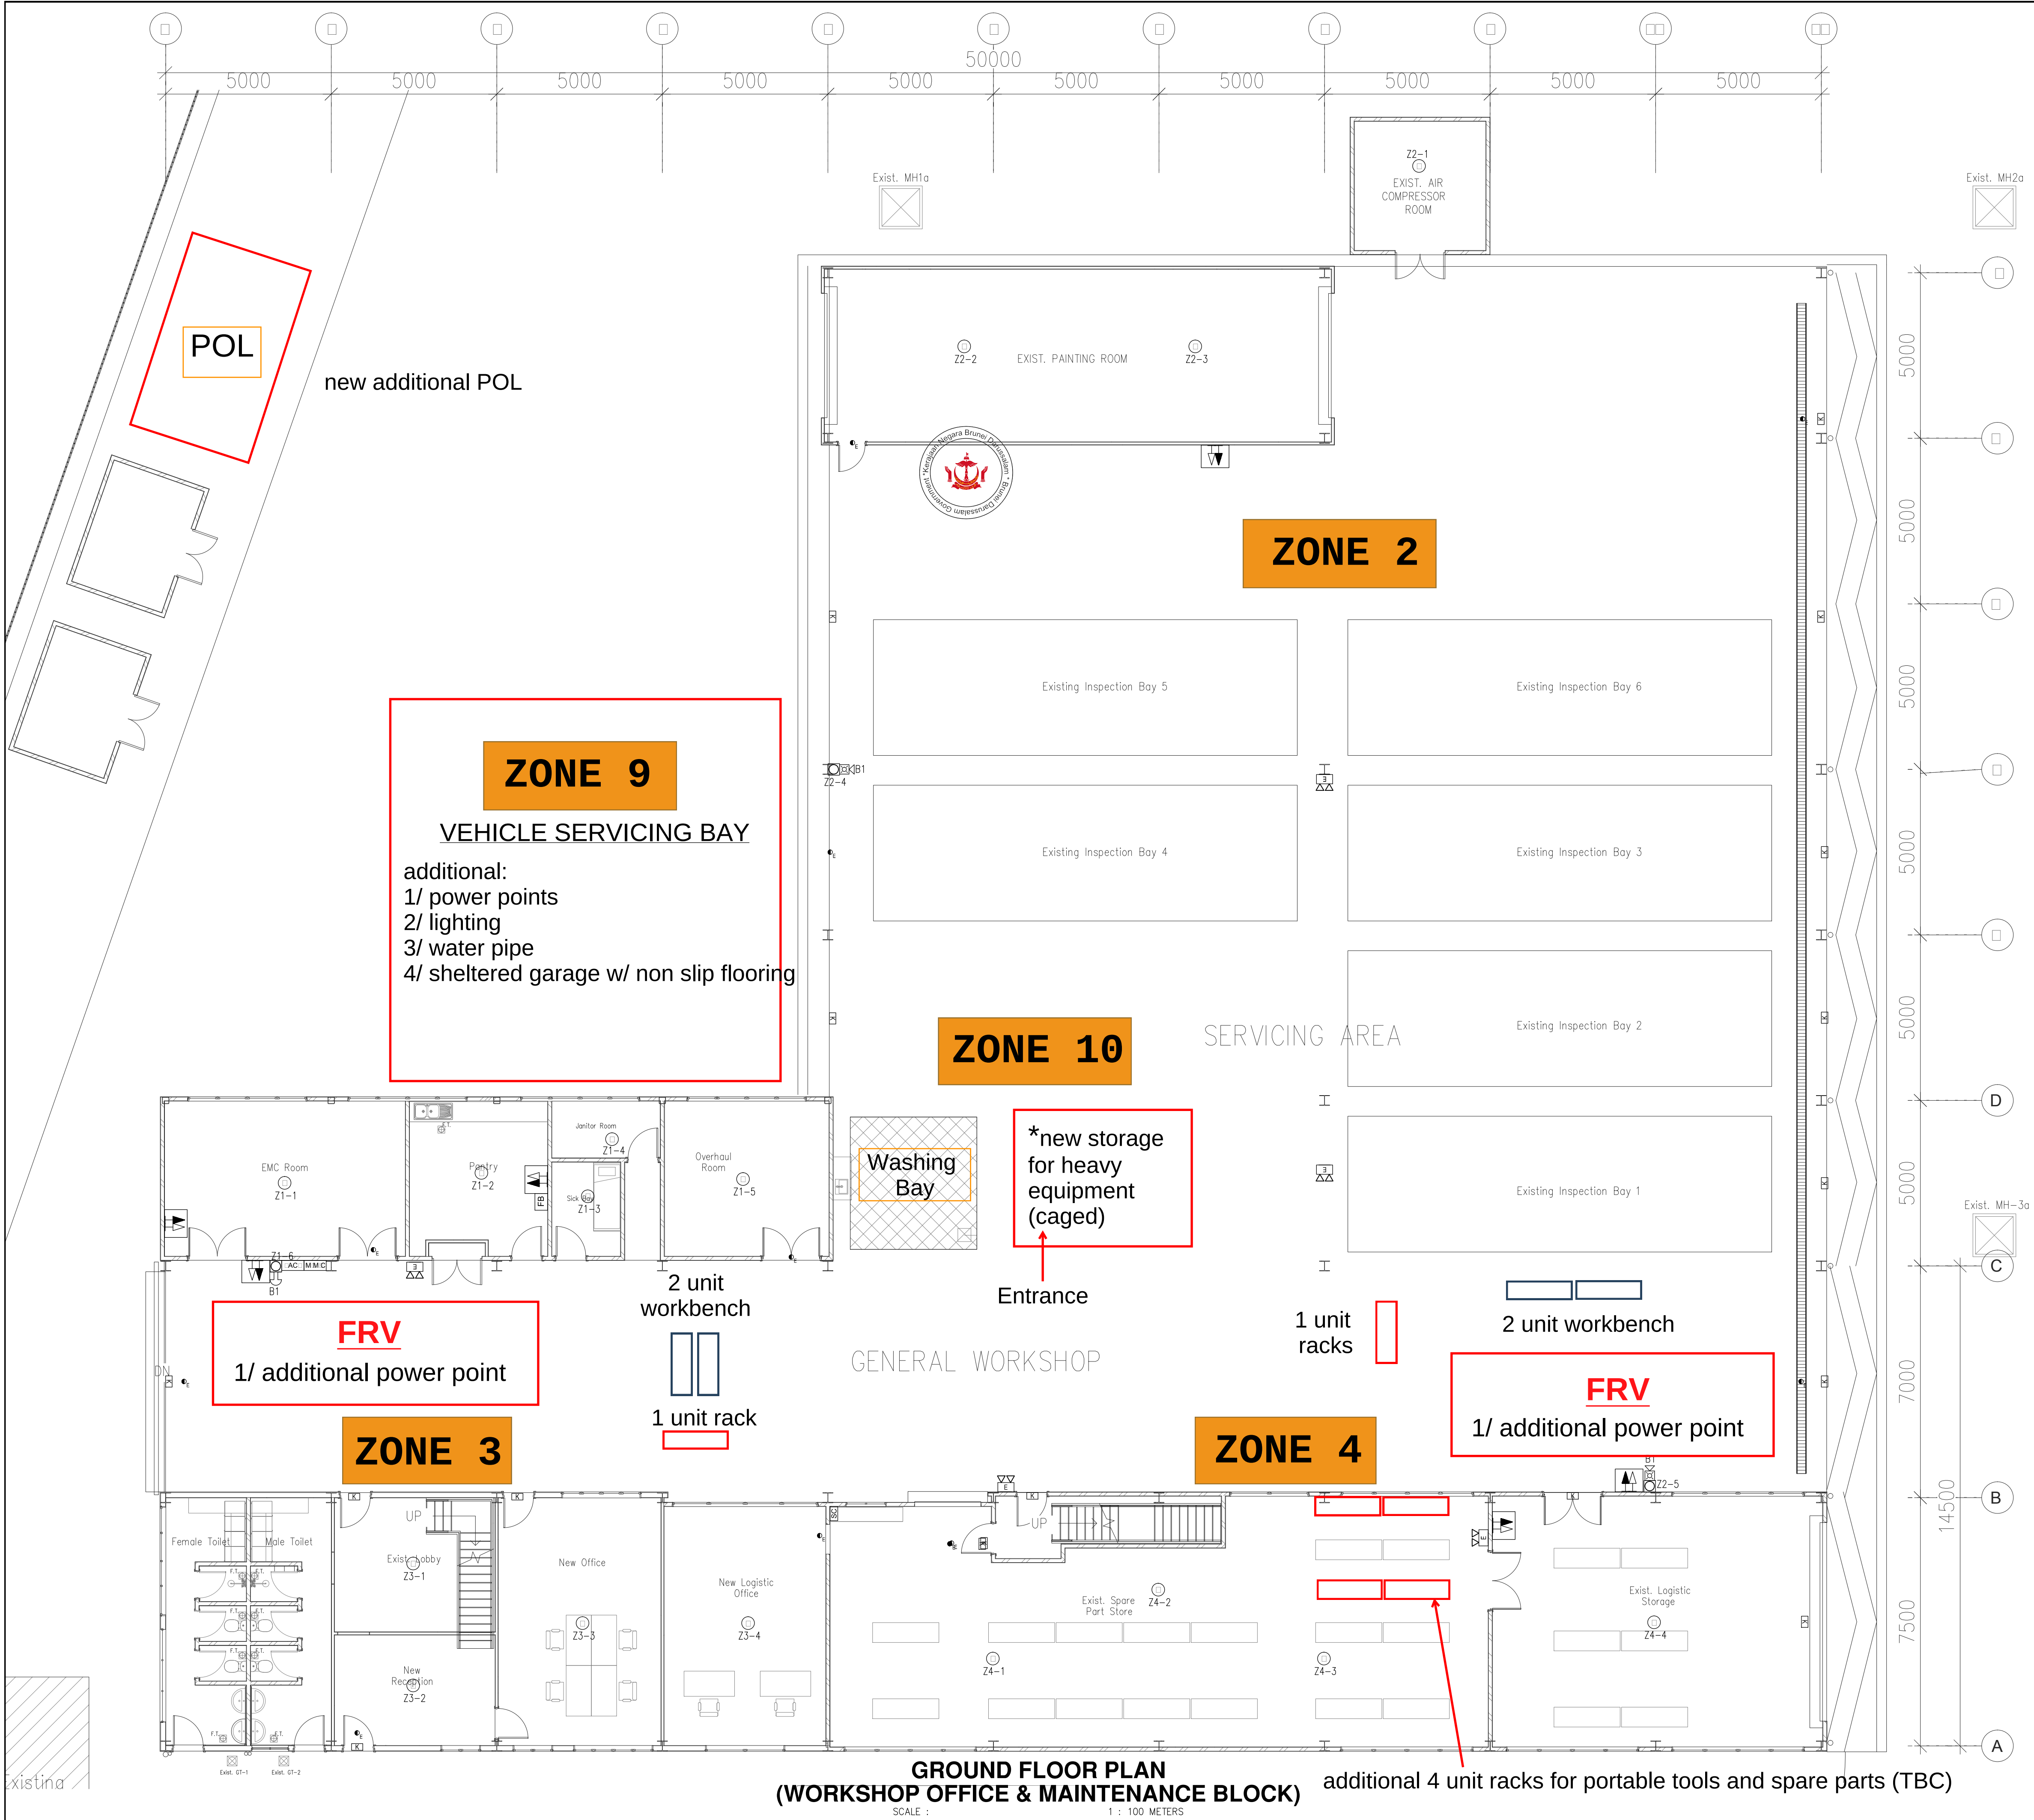


SYMBOL	DESCRIPTION
	MANUAL CALL POINT SIMILAR OR COMPATIBLE TO EXISTING BRAND TO BOMBA APPROVED TYPE
	FIRE ALARM BELL SIMILAR OR COMPATIBLE TO EXISTING BRAND TO BOMBA APPROVED TYPE
	FIRE ALARM SOUNDER SIMILAR OR COMPATIBLE TO EXISTING BRAND TO BOMBA APPROVED TYPE
	SMOKE DETECTOR SIMILAR OR COMPATIBLE TO EXISTING BRAND TO BOMBA APPROVED TYPE
	HEAT DETECTOR SIMILAR OR COMPATIBLE TO EXISTING BRAND TO BOMBA APPROVED TYPE
	9.0 KG ABC DRY POWDER & 2.5 KG CO2 FIRE EXTINGUISHER C/W WEATHER PROOF CABINET BRACKET TO BOMBA APPROVED TYPE
	FIRE BLANKET TO BOMBA APPROVED TYPE.
	MIMIC PANEL WITH LED ZONING INDICATOR
	FIRE ALARM CONTROL PANEL

ZONE 8

VEHICLE SERVICING/ INSPECTION PIT

additional:
1/ power points
2/ lighting
3/ water pipe
4/ inspection pit 4-5ft
5/ sheltered garage w/ non slip flooring
6/ Fire Extinguisher (dry powder)

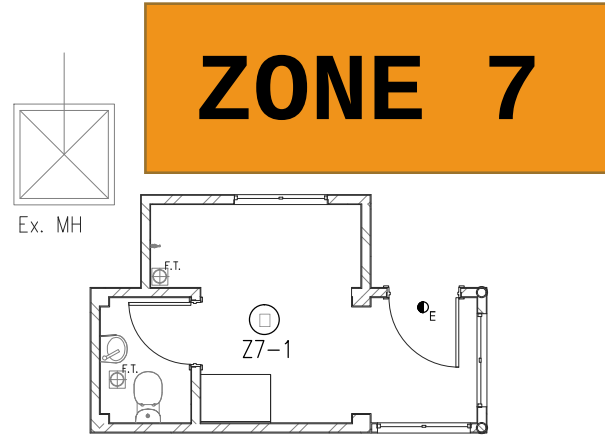

GROUND FLOOR PLAN (GUARD HOUSE)

SCALE : 1 : 100 METERS

additional 4 unit racks for portable tools and spare parts (TBC)